

DETAIL 1  
ACCESS CHAMBER (TYPICAL)  
NOT TO SCALE

PLUMBING DESIGN CERTIFIED BY:

*[Signature]*

14 / 09 / 2021

DES MARTIN 20873PD

ALL WORKS ARE TO BE CARRIED OUT BY AN ACCREDITED POWERWATER CONSTRUCTOR

**CAUTION:**  
THE EXISTING POWER POLE IS TO BE BRACED AND SUPPORTED PRIOR TO STARTING ANY DEEP EXCAVATIONS.

**CAUTION:**  
THE EXISTING POWER POLE IS TO BE BRACED AND SUPPORTED PRIOR TO STARTING ANY DEEP EXCAVATIONS.

PERMISSION TO USE FOR CONSTRUCTION PURPOSES ONLY  
SIGNED \_\_\_\_\_ DATE 15/9/2021  
ON BEHALF OF WATER SERVICES FOR THE INCORPORATION INTO POWER AND WATER CORPORATION'S NETWORK.  
This permission to use this approved design is given on the Basis that the developer and/or consultant is not absolved From full responsibility for the correctness and accuracy or Of the design and/or documents so associated.



This drawing is valid for 2 years from the date of signing

ACCESS CHAMBER LINE NO.  
ACCESS CHAMBER TYPE  
ACCESS CHAMBER DROP TYPE  
ACCESS COVER TYPE  
ACCESS CHAMBER NUMBER

ACCESS COVER TYPE  
LEGEND:  
CIRCULAR AC - C  
RECTANGLE LID - R  
HEAVY DUTY - D

PIPE TYPE & CLASS: uPVC-SN8  
LENGTH - DIAMETER: 77.216-DN150  
GRADE: 1.100  
DATUM RL: 17.015

RL TOP OF ACCESS CHAMBER	17.025	17.160
DEPTH TO INVERT	1.798	1.828
INVERT LEVEL	15.227	14.417
FINISHED SURFACE LEVEL	17.000	17.160
NATURAL SURFACE	17.160	17.160
CHAINAGE	77.20m	0.00m

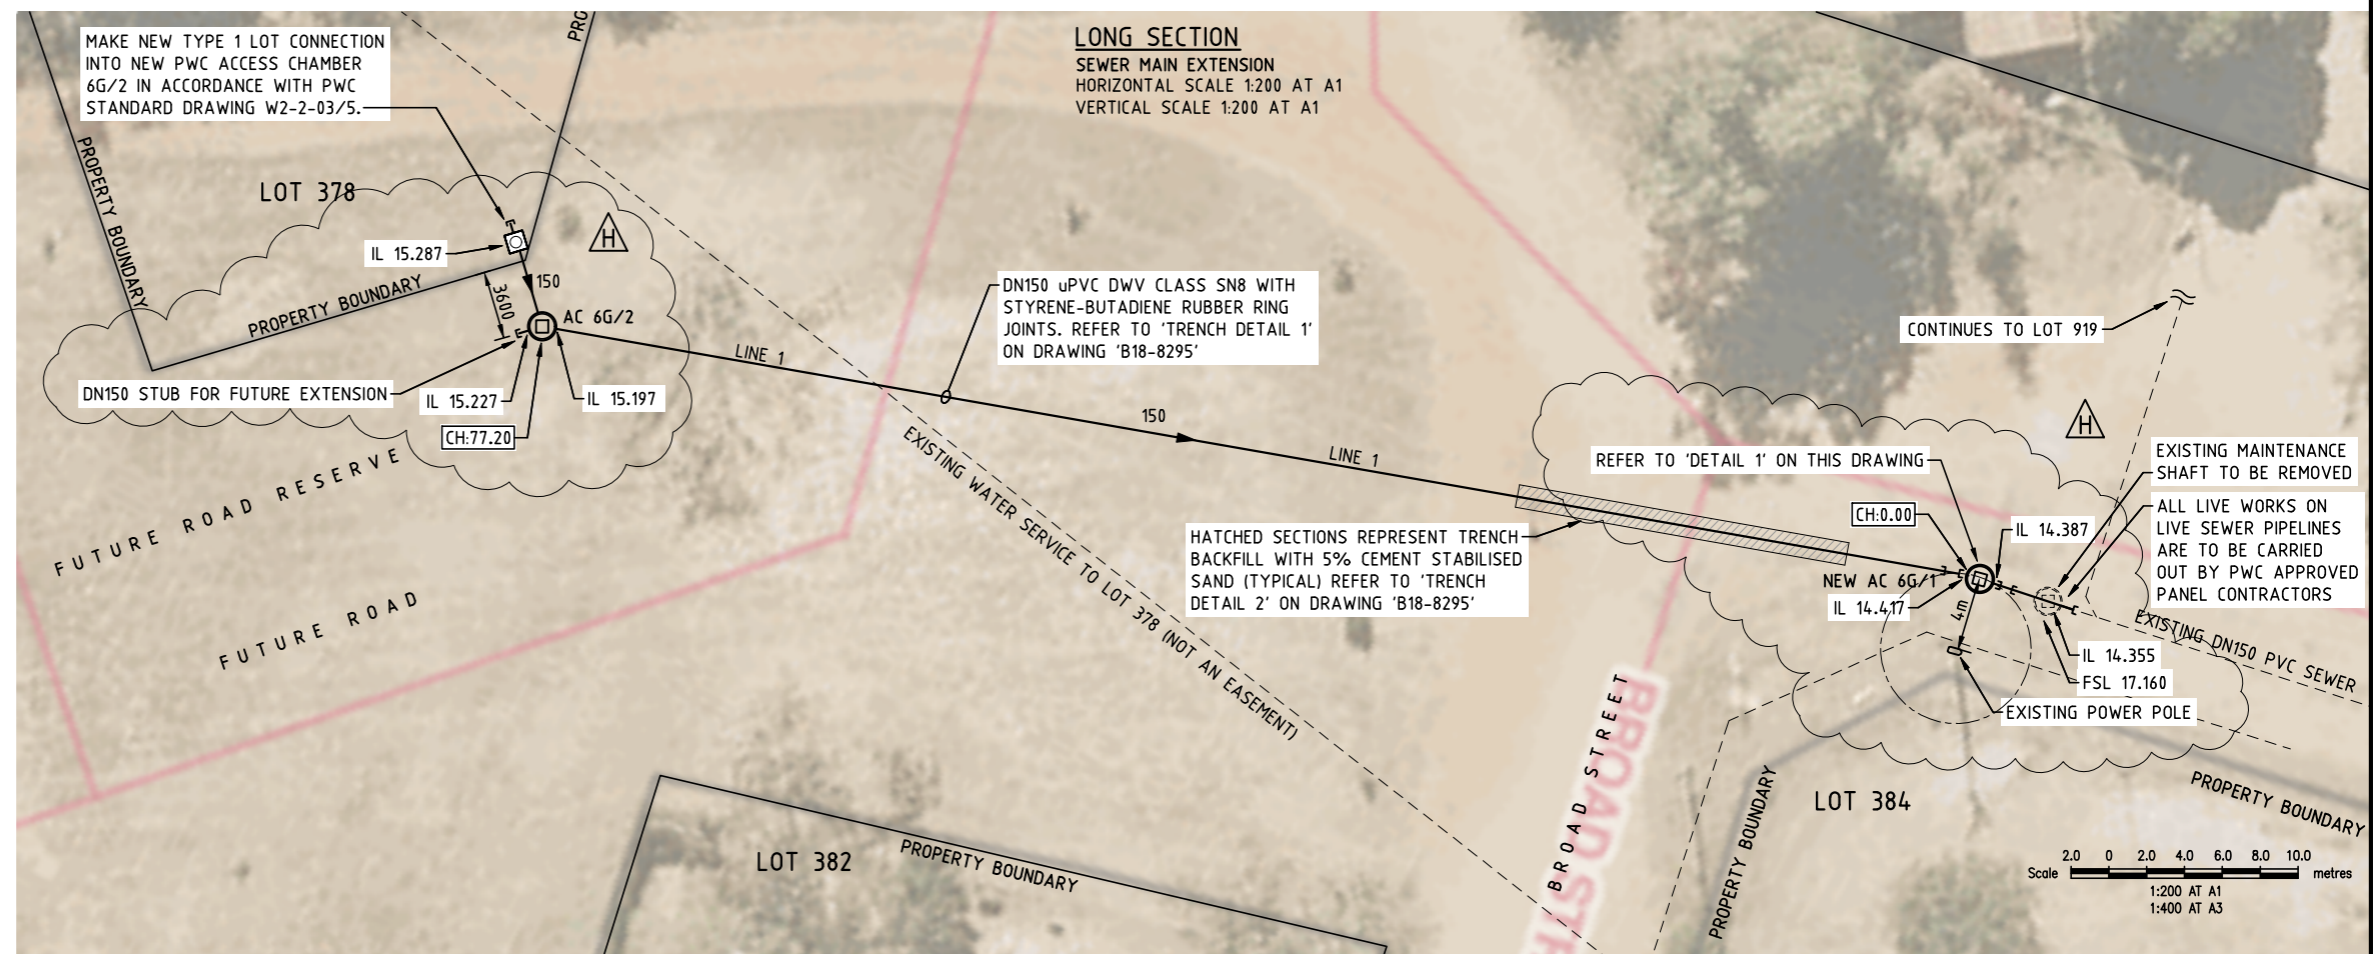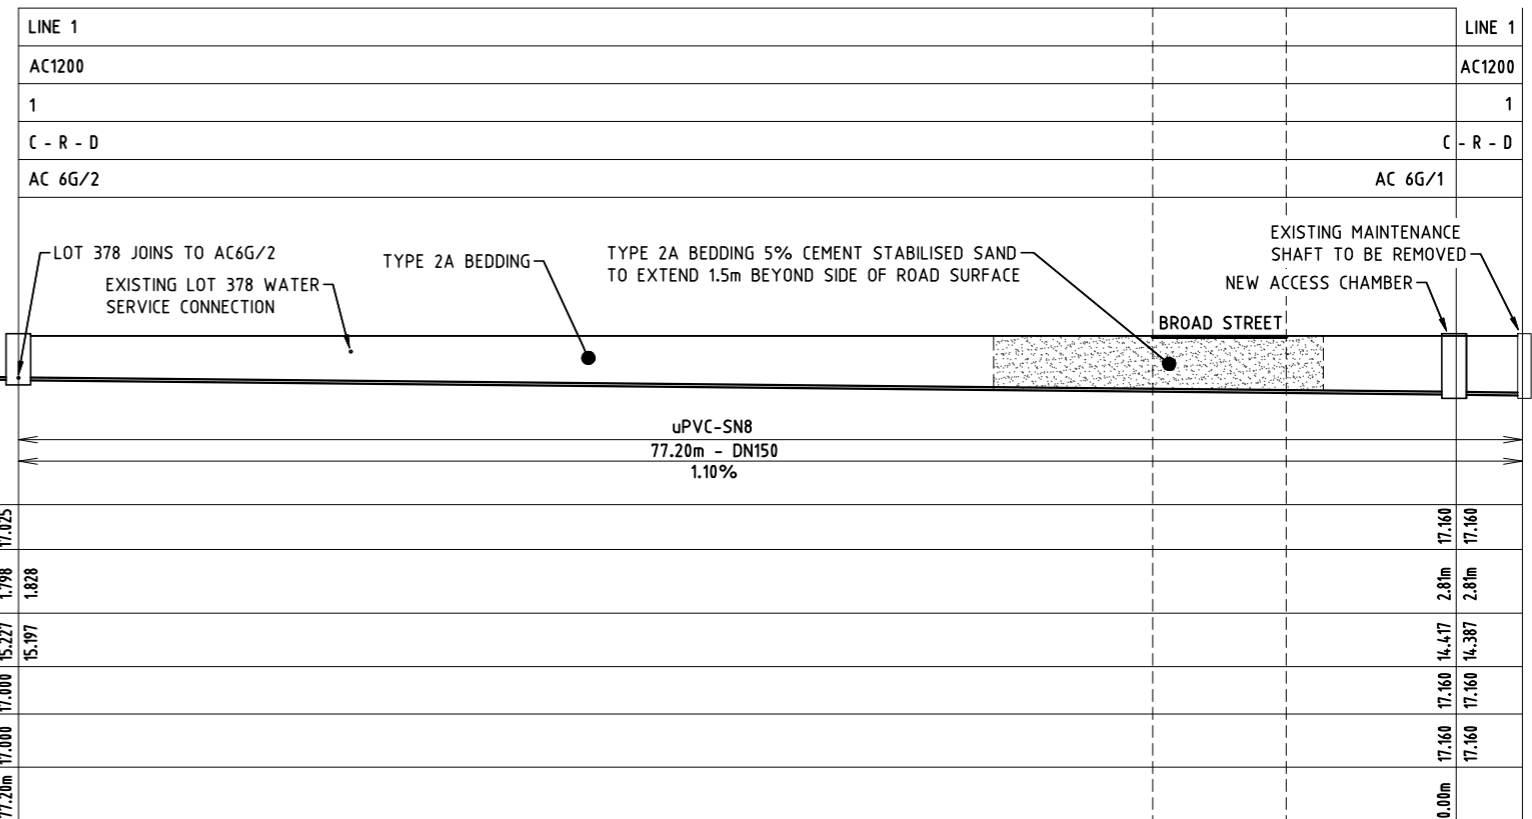

SITE PLAN  
SEWER MAIN EXTENSION  
SCALE 1:200 AT A1

H	SEWER LINE 2 REMOVED- ISSUED FOR APPROVAL/CONSTRUCTION	DM	14/09/2021	RA	
G	ISSUED FOR APPROVAL / CONSTRUCTION	RA	27/08/2021	DM	
F	ISSUED FOR APPROVAL / CONSTRUCTION	DG	10/02/2021	DM	
E	ISSUED FOR APPROVAL / CONSTRUCTION	DG	11/03/2020	DM	
D	ISSUED FOR COMMENT / REVIEW	DG	22/01/2020	DM	
C	ISSUED FOR COMMENT / REVIEW	DG	20/06/2018	DM	
B	ISSUED FOR COMMENT / REVIEW	DG	04/06/2018	DM	
A	ISSUED FOR COMMENT / REVIEW	DG	23/05/2018	DM	
NO	DESCRIPTION	DRN	DATE	CKD	APPD
	AMENDMENTS				

DES	DM
DRN	DM
CHK	RA
APPD	IL
SCALE	AS SHOWN
ISSUED	14/09/21
ALL DIM. IN mm	
DRAFTING STANDARD TO A.S.1100	

**aws**  
ARCHITECTURAL WATER SOLUTIONS

Architectural Water Solutions  
ABN 84 140 482 908  
P.O. Box 2112  
PARAP NT 0804

Phone : 08 8947 3677  
Fax : 08 8947 3699  
Mobile : 0419 835 686  
Email : design@awsdesign.com.au

**WARNING**  
BEWARE OF SERVICES  
THE LOCATIONS OF ALL EXISTING SERVICES ARE APPROXIMATE ONLY AND THEIR EXACT POSITION SHOULD BE PROVEN ON SITE. NO GUARANTEE IS GIVEN THAT ALL EXISTING SERVICES ARE SHOWN.

**PowerWater**  
NORTHERN TERRITORY

NORTHERN REGION - DARWIN, NT		LOT 378 BORROLOOLA		DN150 SEWER MAIN EXTENSION / LOT CONNECTION	
SITE PLAN & LONG SECTION		DRAWING NUMBER		B18-8296	
A1		H		AMDT	
CAD PRODUCT - DO NOT AMEND MANUALLY					